

# Attachment 1


Revision History	Rev. Date	Draw By	Checked By	Approved By
Rev.: 1	August 15 <sup>th</sup> ,2017	R&D Gov Team	R&D Gov Team	R&D Gov Team
Rev.:				
Rev.:				

## System Overview Power Plant Control System MNG-H1

Electricity Generating Authority of Thailand

Drawing No.:	Size A4
File: 1.1_MNG_Attach_rev1.AUGUST 15 <sup>th</sup> ,2017	Pages -/-


# Attachment 2

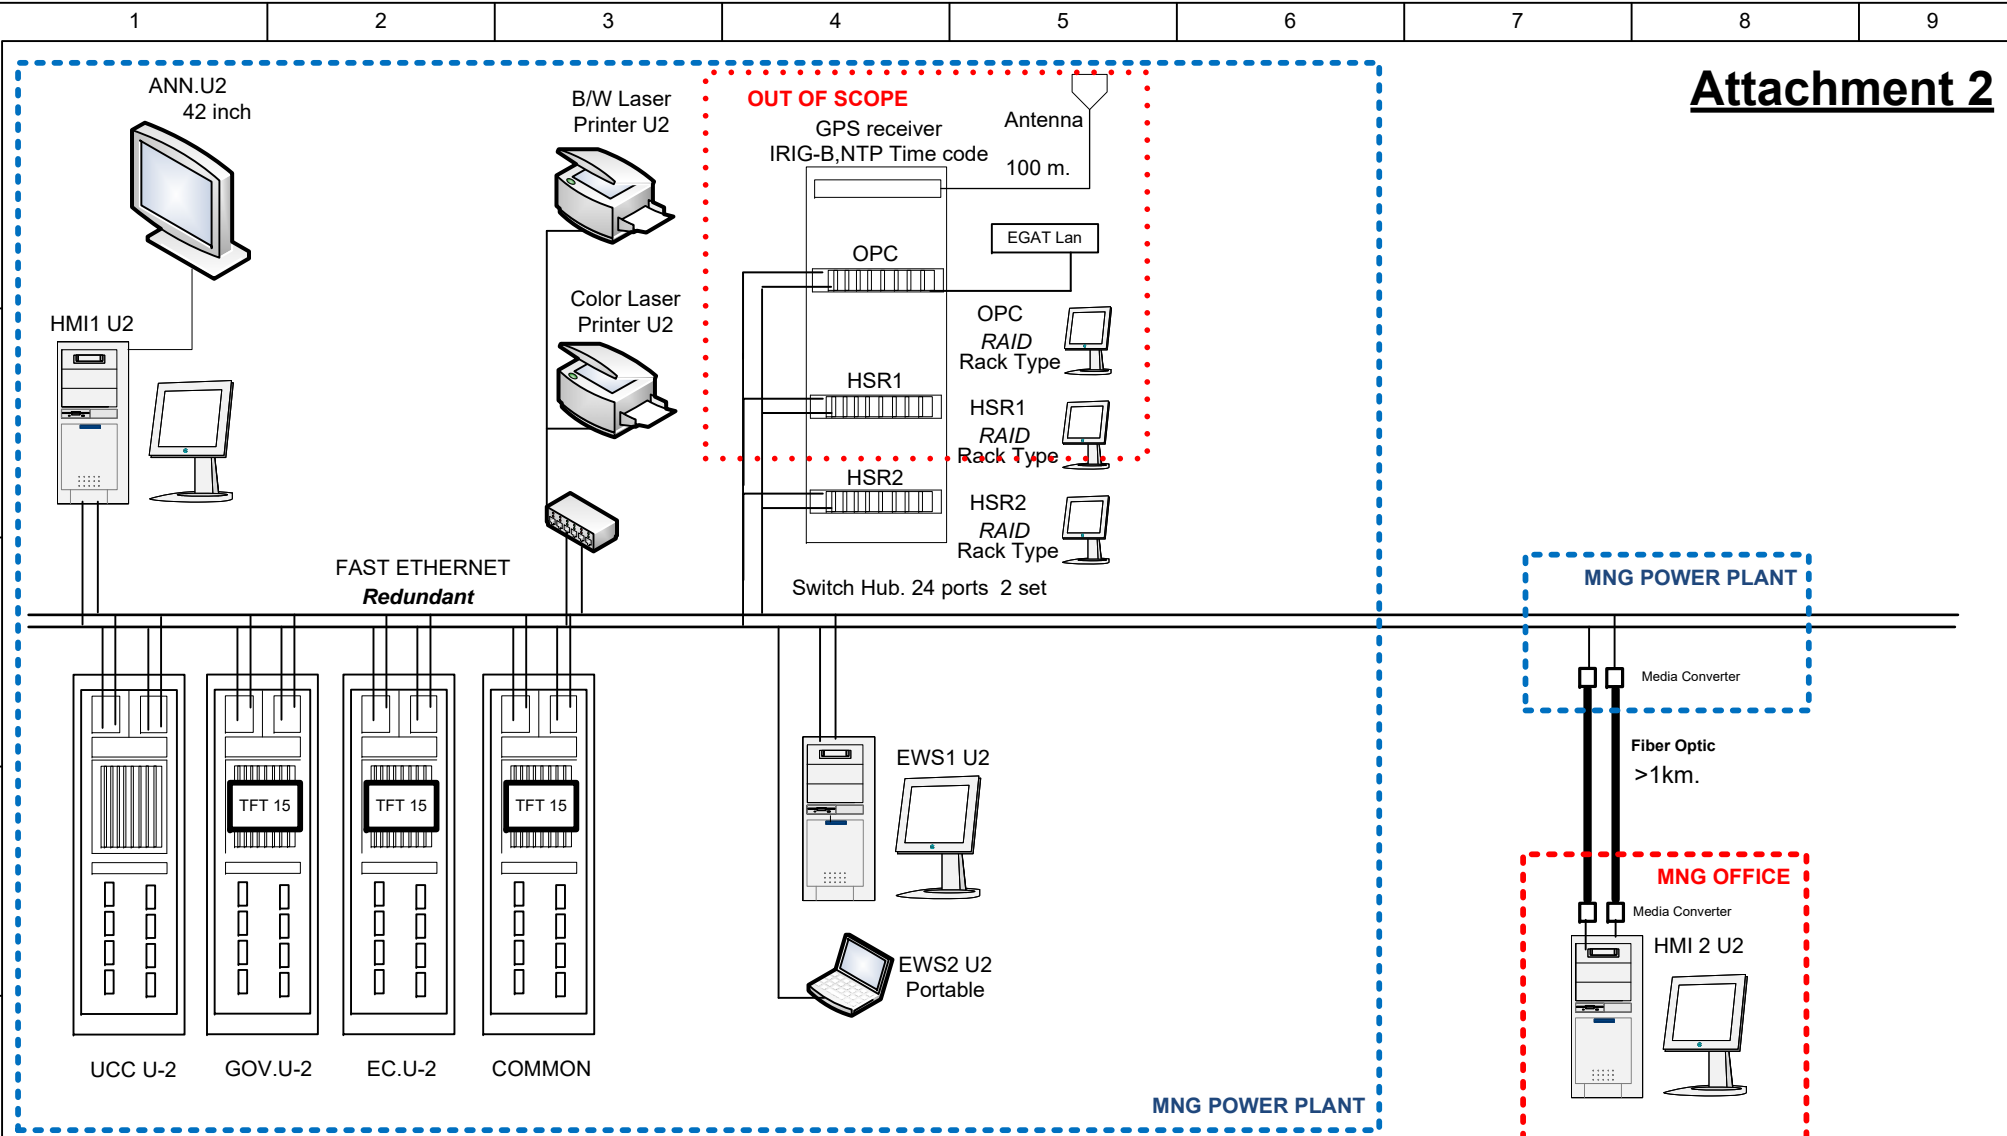

Revision History	Rev. Date	Draw By	Checked By	Approved By
Rev.: 1	August 15 <sup>th</sup> ,2017	R&D Gov Team	R&D Gov Team	R&D Gov Team
Rev.:				
Rev.:				

## System Overview Power Plant Control System MNG-H2

Electricity Generating Authority of Thailand	
Drawing No.:	Size A4
File: 1.1_MNG_Attach rev1.AUGUST 15 <sup>th</sup> ,2017	Pages -/-

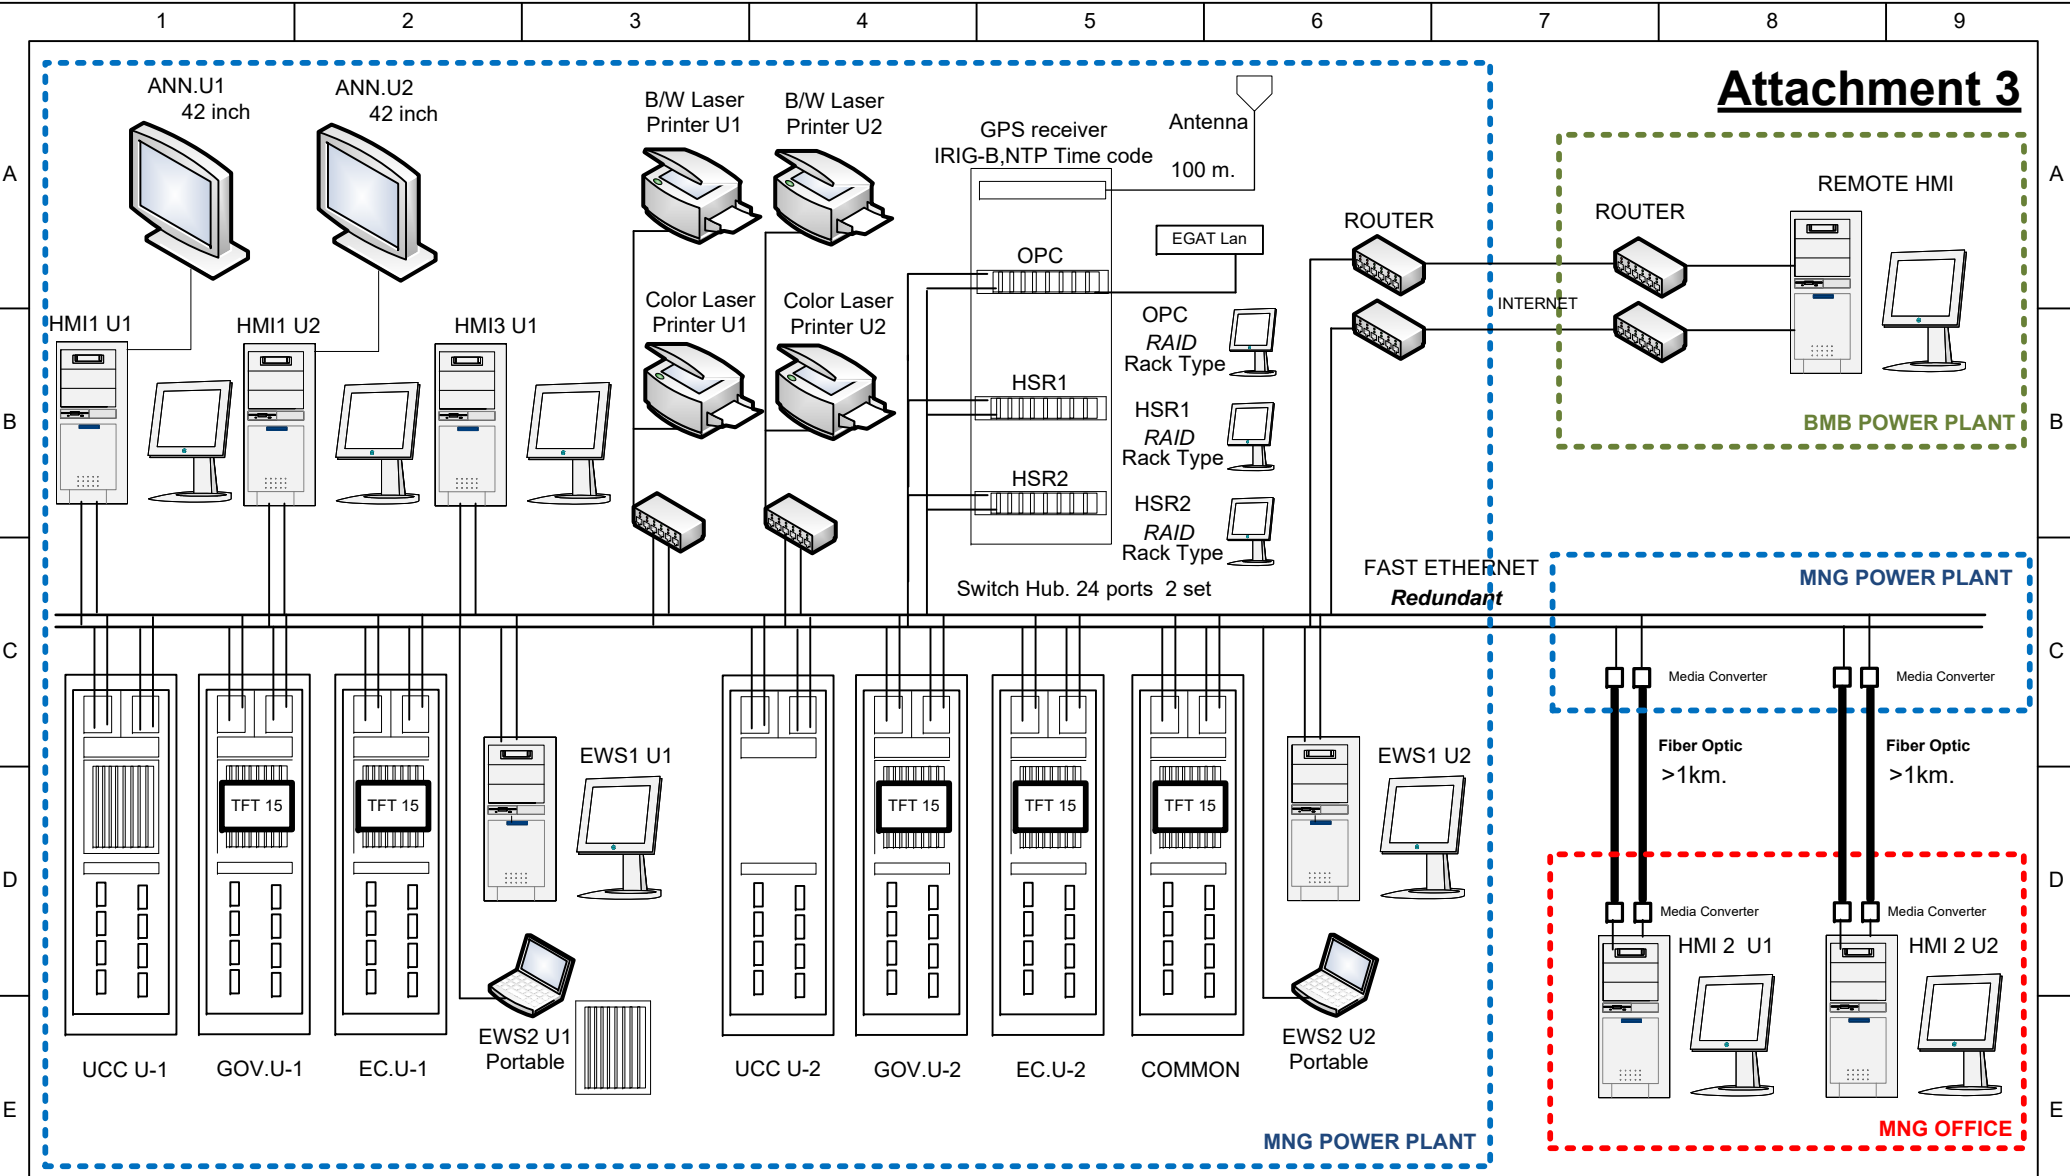

Revision History	Rev. Date	Draw By	Checked By	Approved By
Rev.: 1	August 15 <sup>th</sup> , 2017	R&D Gov Team	R&D Gov Team	R&D Gov Team
Rev.:				
Rev.:				

# Overall System Overview

## Power Plant Control System MNG-H1,2

Electricity Generating Authority of Thailand

Drawing No.:	Size A4
File: 1.1_MNG_Attach rev1.AUGUST 15 <sup>th</sup> , 2017	Pages -/-