

DOCUMENT STATUS	
FOR COMMENT	<input checked="" type="checkbox"/>
COMMENTED	<input type="checkbox"/>
APPROVED WITH COMMENTS	<input type="checkbox"/>
APPROVED FOR DESIGN/CONSTRUCTION	<input type="checkbox"/>
REJECTED	<input type="checkbox"/>
AS-BUILT	<input type="checkbox"/>



SYSTEM ARCHITECTURE DIAGRAM

CHAO PHRAYA UNIT CONTROL & GOVERNOR CONTROL SYSTEM 1 & 2

RENOVATION PROJECT

						<p>TERMS OF USE: THESE TERMS GOVERN THE USE OF THE ACCOMPANYING DRAWINGS. BY USING THE DRAWINGS IN ANY MANNER, YOU ACCEPT THESE TERMS. IF YOU DO NOT ACCEPT THE TERMS, DO NOT USE THE DRAWINGS.</p> <p>1. YOU ARE PROHIBITED FROM USING THE DRAWINGS TO BUILD OR ENGAGE ANY THIRD PARTY TO BUILD ANY PRODUCTS (E.G., CABINETS/PANELS) DEPICTED BY THE DRAWINGS.</p> <p>2. ANY MODIFICATION OF THE PRODUCT DEPICTED BY THESE DRAWINGS, WHETHER MADE BY YOU OR A THIRD PARTY, NULLIFIES ANY APPROVALS REFERENCED OR SPECIFIED IN THE DRAWINGS OR PRODUCT LITERATURE.</p> <p>3. ANY COPIES AND/OR DISTRIBUTION OF THE DRAWINGS SHALL RETAIN THESE TERMS AND ANY INTELLECTUAL PROPERTY (E.G., COPYRIGHT) NOTICES, TRADEMARKS, AND/OR EMERSON'S LOGO OR NAME, WHICH APPEAR ON THE DRAWINGS. YOU WILL ALSO INFORM ANY END-USERS (I.E., CUSTOMERS) ABOUT THE TERMS SET FORTH HEREIN.</p>
0	ISSUED FOR APPROVAL	26-MAR-2020	NZ	SW	JT	
REV.	DESCRIPTION	DATE	DRAWN BY	CHECKED BY	APPROVED BY	

LIBRARY REVISION:

PERMIT STAMP AND PROFESSIONAL STAMP AFFIXED ABOVE SHALL APPLY ONLY TO REV(S) 0			CLIENT PROJECT NUMBER: N/A	PROJECT TITLE: CHAO PHRAYA UNIT CONTROL & GOVERNOR CONTROL SYSTEM 1 & 2	END USER: ELECTRICITY GENERATING AUTHORITY OF THAILAND	SHT.
			EMERSON PROJECT NUMBER: 3280234	DRAWING TITLE: COVER SHEET	CLIENT: XXXX	01 OF 05
			CONTRACT NUMBER: N/A		EMERSON DRAWING NO. EMR-OVA-E-002	REV.
			DRAWN BY: NT DATE: 26-MAR-2020		CLIENT DRAWING NO. N/A	0
			CHECKED BY: SW DATE: 26-MAR-2020			
			APPROVED BY: JT DATE: 26-MAR-2020			
			SCALE: NTS SIZE: A3 UNITS: MM © 2009-19			

TABLE OF CONTENTS		
SR NO	DESCRIPTION	SHEET NO.
1	COVER SHEET	1
2	INDEX SHEET	2
3	CONTENTS, ABBREVIATION LIST & LEGENDS	3
4	OVATION DCS SYSTEM ARCHITECTURE	4
5	3RD PARTY COMMUNICATION CONNECTION DRAWING	5

LIBRARY REVISION :

PERMIT STAMP AND PROFESSIONAL STAMP AFFIXED ABOVE SHALL APPLY ONLY TO REV(S)

0



 
 



 

 

 

 



CLIENT PROJECT NUMBER:	N/A
EMERSON PROJECT NUMBER:	3280234
CONTRACT NUMBER:	N/A
DRAWN BY:	NT
CHECKED BY:	SW
APPROVED BY:	JT
SCALE:	NTS
SIZE:	A3
UNITS:	MM
DATE:	26-MAR-2020
DATE:	26-MAR-2020
DATE:	26-MAR-2020
©	2009-19








PROJECT TITLE: CHAO PHRAYA UNIT CONTROL & GOVERNOR CONTROL SYSTEM 1 & 2
 DRAWING TITLE: INDEX SHEET

END USER: ELECTRICITY GENERATING AUTHORITY OF THAILAND	
CLIENT: XXXX	
EMERSON DRAWING NO.	EMR-OVA-E-002
CLIENT DRAWING NO.	N/A

SHT.	02
OF	05
REV.	0

CONTENTS, ABBREVIATION LIST & LEGENDS

LEGENDS	DESCRIPTION	LEGENDS	DESCRIPTION
	FO/ETHERNET CONVERTER		ROUTER
	FIBER OPTIC PATCH PANEL		GPS SERVER
	NETWORK SWITCH		
	OCR1100 CONTROLLER		GPS ANTENNA
	4 SLOT I/O BASE ASSEMBLY		MONITOR
	OVATION I/O TRANSITION PANEL		PRINTER
	FIREWALL		OPERATING WORKSTATION
	TOUCH SCREEN HMI		LAPTOP

LEGENDS	
	ETHERNET PRIMARY
	ETHERNET SECONDARY
	PRINTER NETWORK
	HARDWIRED CONNECTION
	MODBUS CONNECTION
	FIBER PRIMARY
	FIBER SECONDARY

ABBREVIATION LIST	
AMS	ASSET MANAGEMENT SYSTEM
AVR	AUTOMATIC VOLTAGE REGULATOR
B/W	BLACK AND WHITE
BKP	BACKUP
BLR	BOILER
CMMS	COMPUTERIZED MAINTENANCE MANAGEMENT SYSTEM
DBS	DATABASE SERVER
DROP	OVATION CONTROLLER/WORKSTATION
DMZ	DEMILITARIZED ZONE
ES	ETHERNET SWITCH
EVAP0	EVAPORATOR
FO	FIBER OPTIC
FO/ETH	FO TO ETHERNET CONVERTER
FOPP	FIBER OPTIC PATCH PANEL
GPS	GLOBAL POSITIONING SYSTEM
IP TRF	INTERNET PROTOCOL TRAFFIC
LED	LIGHT EMITTING DIODE
NWS	NETWORK SWITCH
NAS	NETWORK ATTACHED STORAGE
OPC	OPEN PRODUCT CONNECTIVITY
OPH	OVATION PROCESS HISTORIAN
OVS	OPERATOR WORK STATION
PB	PROFIBUS
PMS	POWER MANAGEMENT SYSTEM
PP	POWER PLANT
PRI	PRIMARY
RIO	REMOTE INPUT OUTPUT
ROP	OVATION I/O TRANSITION PANEL
SEC	SECONDARY
SIS	SAFETY INSTRUMENTED SYSTEM
SYN	SYNCHRONIZATION
UPS	UNINTERRUPTIBLE POWER SUPPLY
VMS	VIBRATION MONITORING SYSTEM
OSC	OVATION SECURITY CENTER
RTR	ROUTER
CON	CONSOLE
VAMS	VEOLIA ASSET MANAGEMENT SYSTEM
HIS	HISTORIAN
NTP	NETWORK TIME PROTOCOL

LIBRARY REVISION :

PERMIT STAMP AND PROFESSIONAL STAMP AFFIXED ABOVE SHALL APPLY ONLY TO REV(s) 0




CLIENT PROJECT NUMBER:	N/A						
EMERSON PROJECT NUMBER:	3280234						
CONTRACT NUMBER:	N/A						
DRAWN BY:	NT	DATE:	26-MAR-2020				
CHECKED BY:	SW	DATE:	26-MAR-2020				
APPROVED BY:	JT	DATE:	26-MAR-2020				
SCALE:	NTS	SIZE:	A3	UNITS:	MM	©	2009-19

PROJECT TITLE: CHAO PHRAYA UNIT CONTROL & GOVERNOR CONTROL SYSTEM 1 & 2
 DRAWING TITLE: CONTENTS, ABBREVIATION LIST & LEGENDS

END USER: ELECTRICITY GENERATING AUTHORITY OF THAILAND	SHT. 03 OF 05
CLIENT: XXXX	
EMERSON DRAWING NO. EMR-OVA-E-002	
CLIENT DRAWING NO. N/A	REV. 0

F
E
D
C
B
A

SYSTEM ARCHITECTURE DIAGRAM

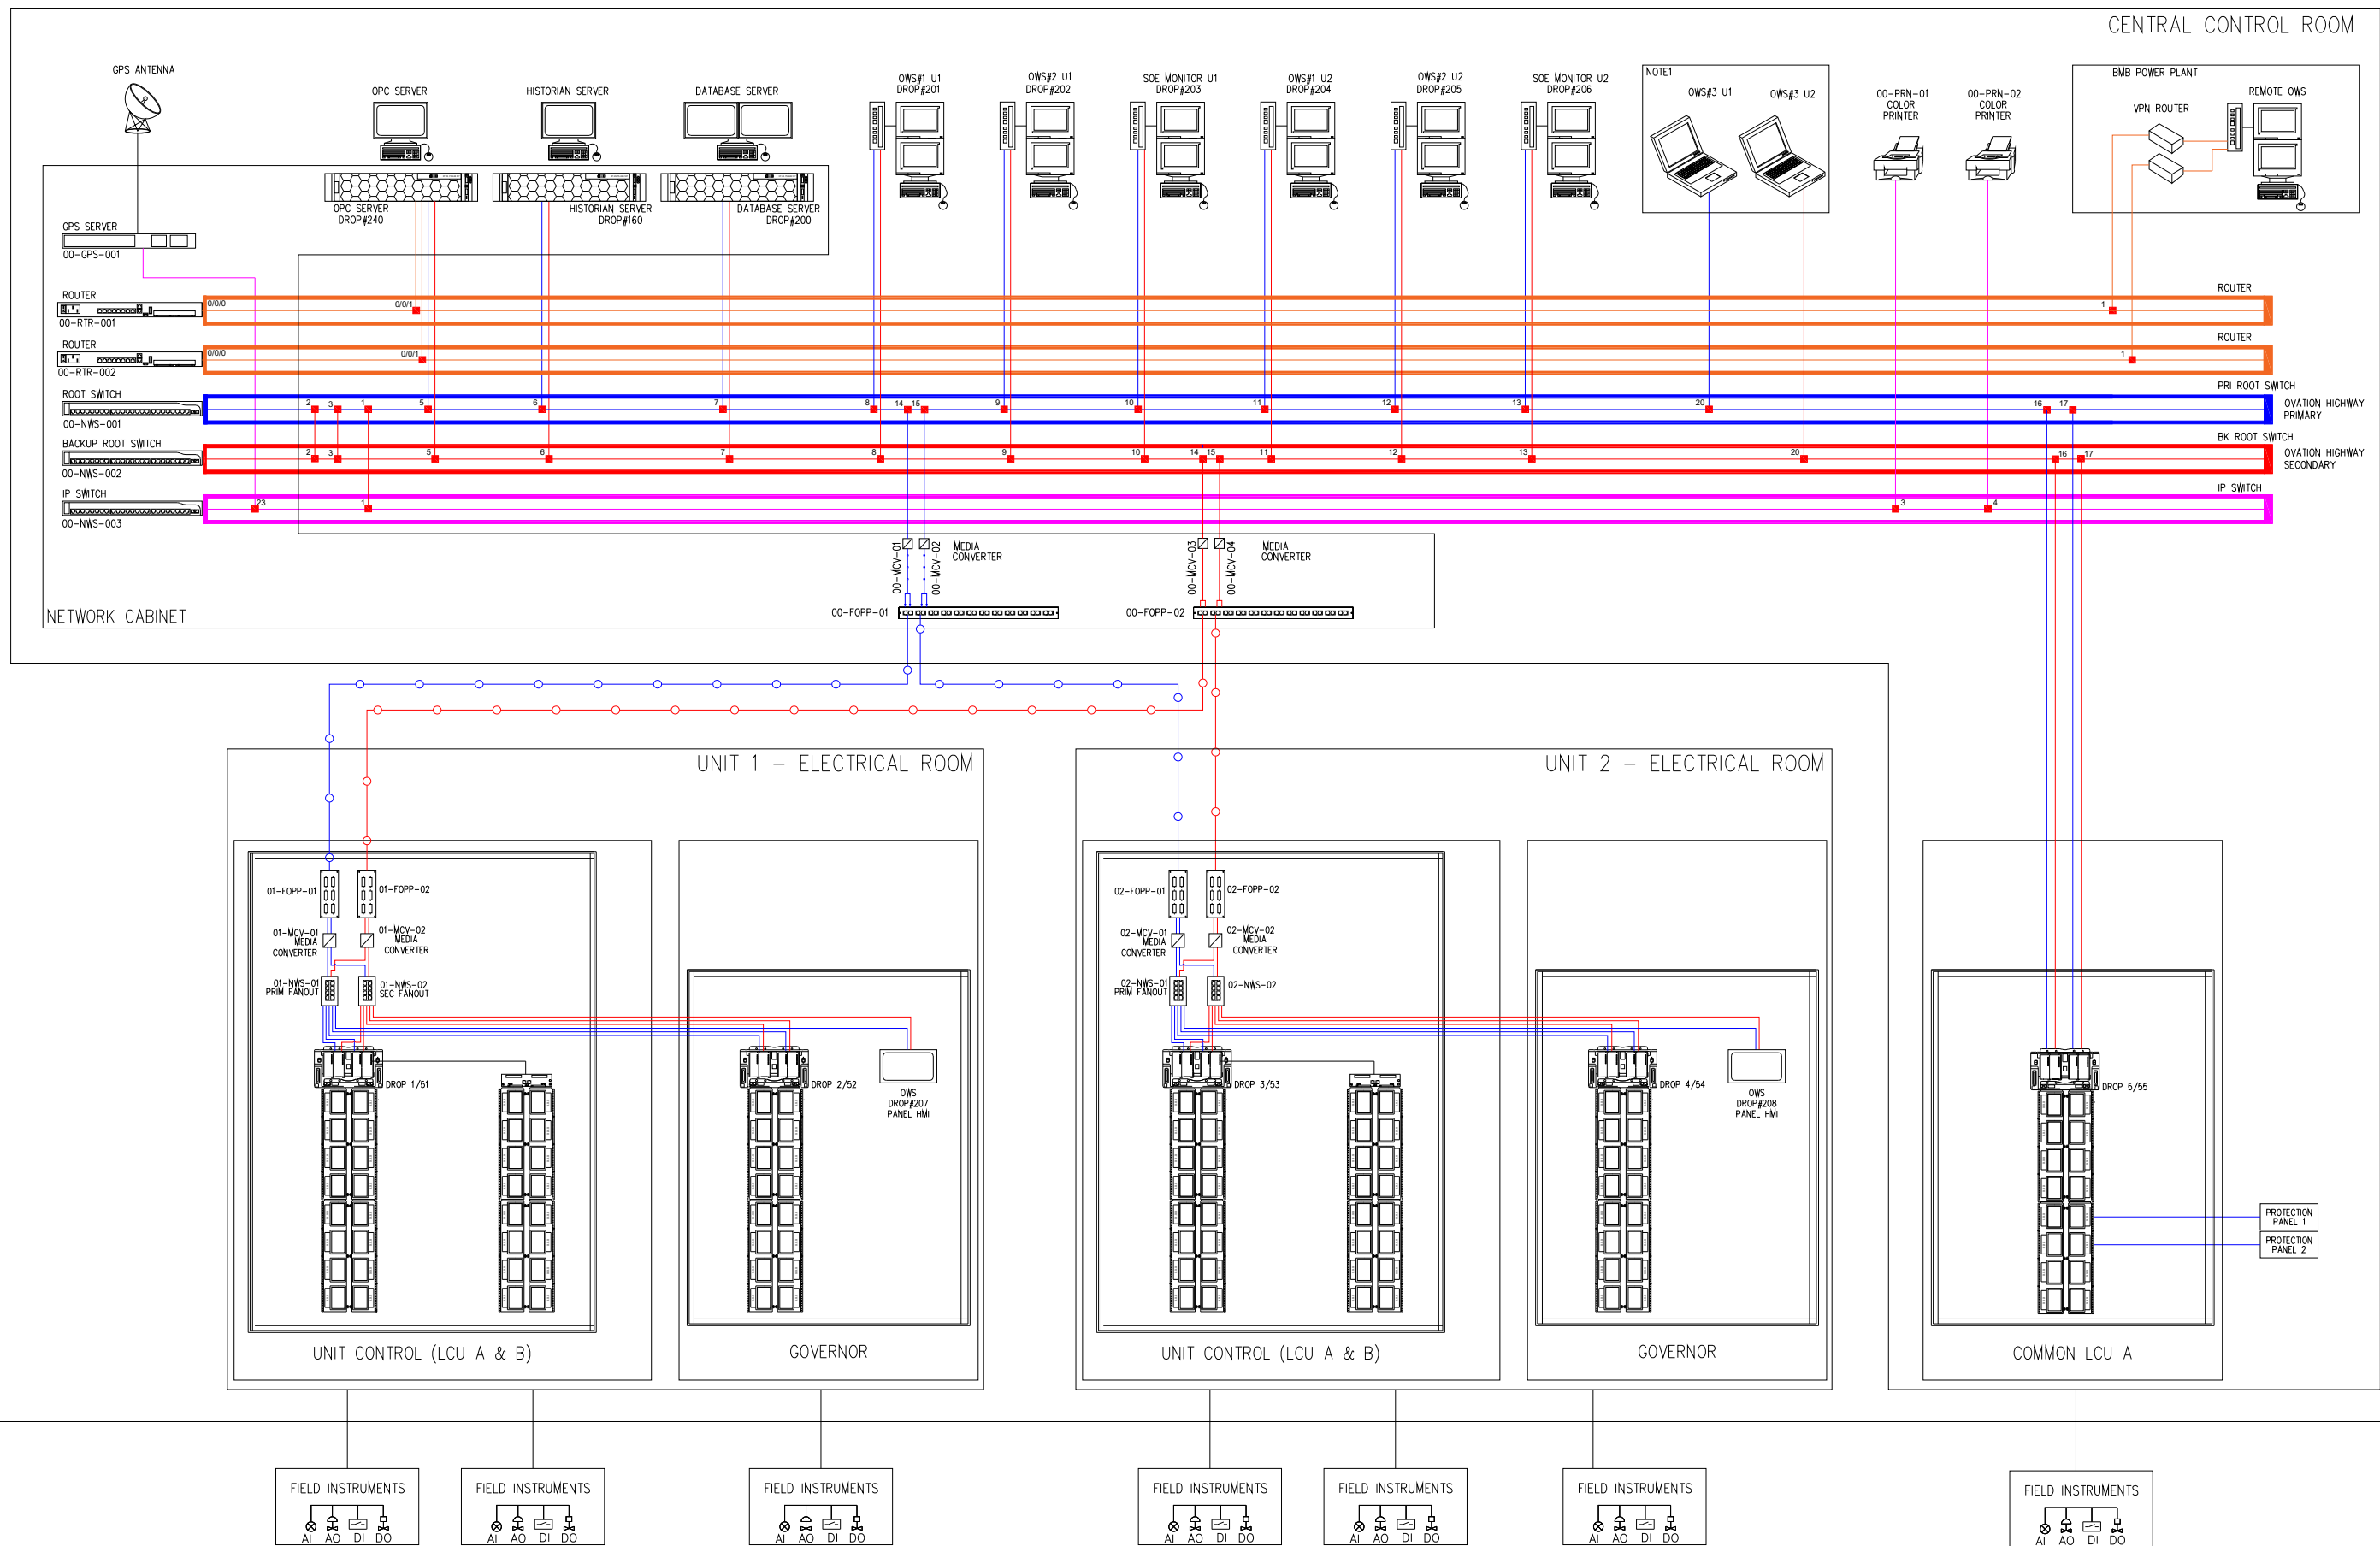

LIBRARY REVISION:

NOTE:
1. THESE ARE PORTABLE DEVICES CAN BE CONNECTED AS REQUIRED.

PERMIT STAMP AND PROFESSIONAL STAMP
AFFIXED ABOVE SHALL APPLY ONLY TO REV(S)

0




CLIENT PROJECT NUMBER:	N/A
EMERSON PROJECT NUMBER:	3280234
CONTRACT NUMBER:	N/A
DRAWN BY:	NT
CHECKED BY:	SW
APPROVED BY:	JT
SCALE:	NTS
SIZE:	A3
UNITS:	MM
DATE:	26-MAR-2020
DATE:	26-MAR-2020
DATE:	26-MAR-2020
©	2009-19

PROJECT TITLE: CHAO PHRAYA UNIT CONTROL & GOVERNOR CONTROL SYSTEM 1 & 2
DRAWING TITLE: SYSTEM ARCHITECTURE DIAGRAM

END USER:	ELECTRICITY GENERATING AUTHORITY OF THAILAND
CLIENT:	XXXX
EMERSON DRAWING NO.:	EMR-OVA-E-002
CLIENT DRAWING NO.:	N/A

SHT.	04
OF	05
REV.	0

3RD PARTY COMMUNICATION CONNECTION DRAWING

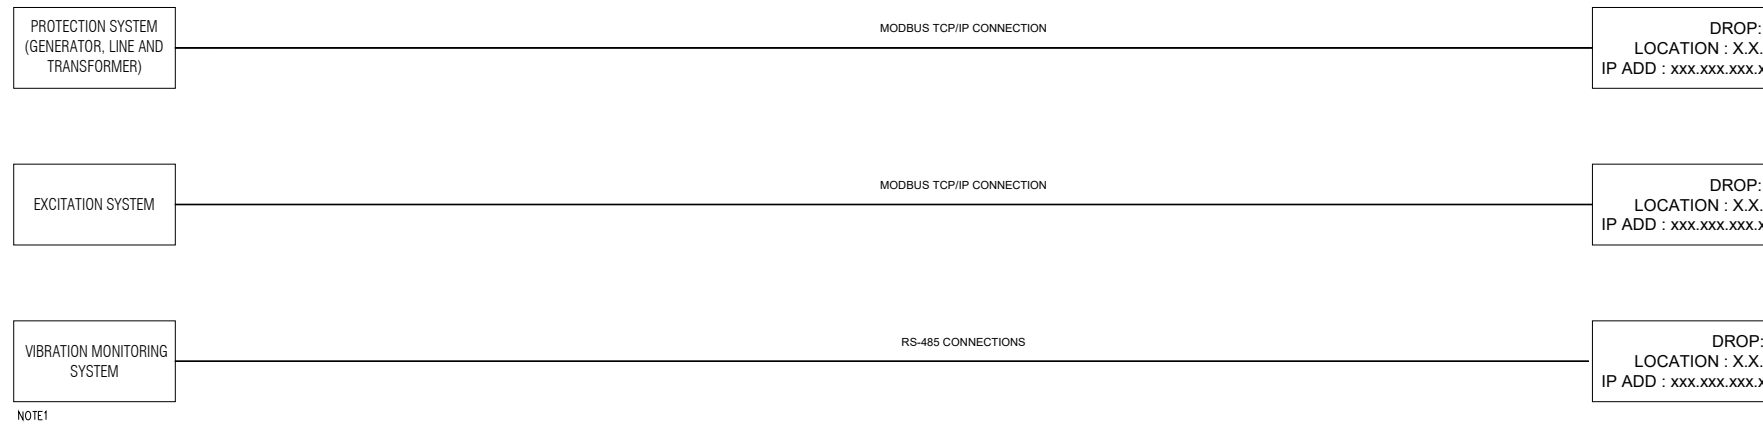

NOTE1

F
E
D
C
B
A

LIBRARY REVISION :

NOTE: 1. SCOPE OF VIBRATION MONITORING SYSTEM NOT YET CONFIRMED.
PERMIT STAMP AND PROFESSIONAL STAMP AFFIXED ABOVE SHALL APPLY ONLY TO REV(s) 0



CLIENT PROJECT NUMBER:	N/A
EMERSON PROJECT NUMBER:	3280234
CONTRACT NUMBER:	N/A
DRAWN BY:	NT
CHECKED BY:	SW
APPROVED BY:	JT
SCALE:	NTS
SIZE:	A3
UNITS:	MM
©	2009-19

PROJECT TITLE: CHAO PHRAYA UNIT CONTROL & GOVERNOR CONTROL SYSTEM 1 & 2
DRAWING TITLE: 3RD PARTY COMMUNICATION CONNECTION DRAWING

END USER: ELECTRICITY GENERATING AUTHORITY OF THAILAND	SHT.
CLIENT: XXXX	05 OF 05
EMERSON DRAWING NO. EMR-OVA-E-002	REV. 0
CLIENT DRAWING NO. N/A	